

The Lower Makefield Veteran's Monument

Veterans Square Foundation

Corner of Heacock and Edgewood Rd, Yardley PA

ARCHITECT



CONSTRUCTION DATA

ISSUE DATE: 03/26/14
 REV DATE:
 CODES: 2009 IBC
 2009 NATIONAL ELECTRIC CODE

DRAWING INDEX

- C-1 COVER SHEET
- A-1 DESIGN CONCEPT / LIGHTING LAYOUT
- A-2 FOUNDATION PLAN
- A-3 SECTION / DETAILS
- A-4 DETAILS / ELEVATIONS

SQUARE FOOTAGE DATA

Linear feet of Wall - 40 linear ft
 Square feet of Wall above grade - 550 sq ft +/-
 Square feet of Interior brick pavers - 1693 sq ft
 Square feet of granite pavers (outside edges) - 1079 sq ft
 Overall Ground Cover of Monument footprint - 2806 sq ft

Location




323 SOUTH YORK ROAD
 HATBORO, PA 19040
 TEL 215.442.1780
 FAX 215.442.1781
 THEOMNIAGROUP.COM




The Lower Makefield Veteran's Monument
Veterans Square Foundation
 Corner of Heacock and Edgewood Rd, Yardley PA

DRAWING DATE
 03/26/14
 REVISION DATES

C-1

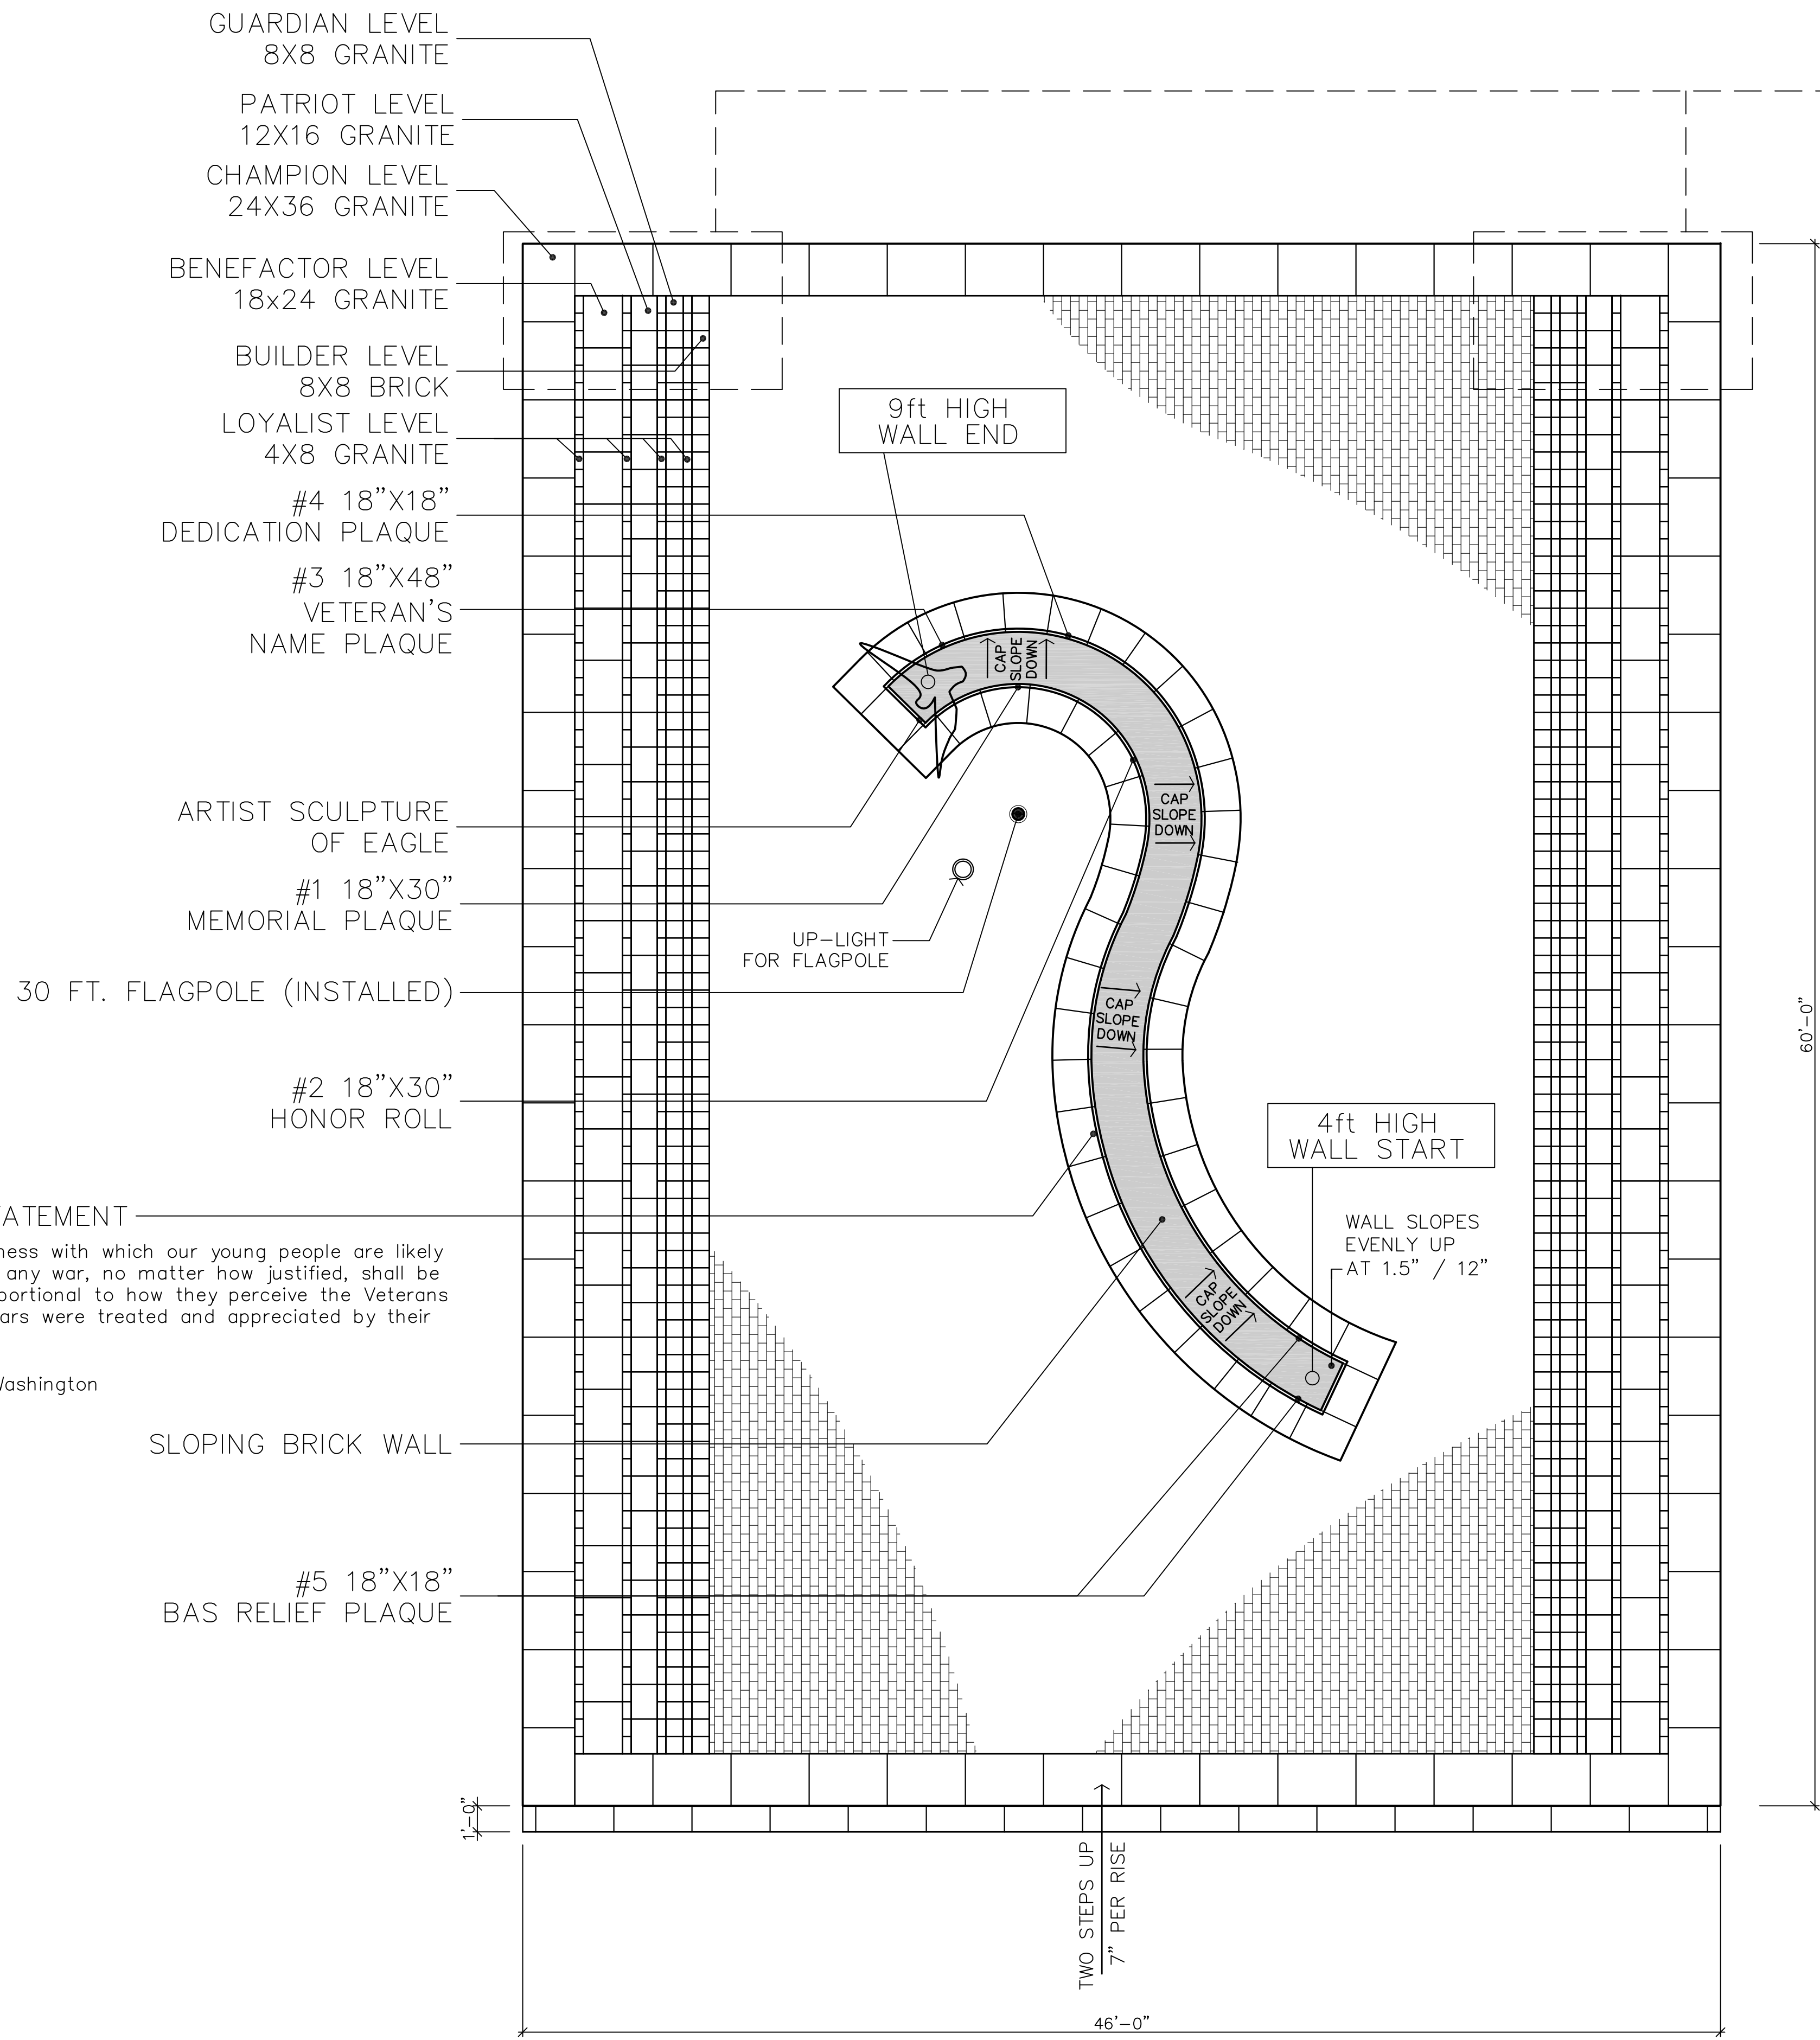

DESIGN CONCEPT
SCALE: 1/4" = 1'-0"

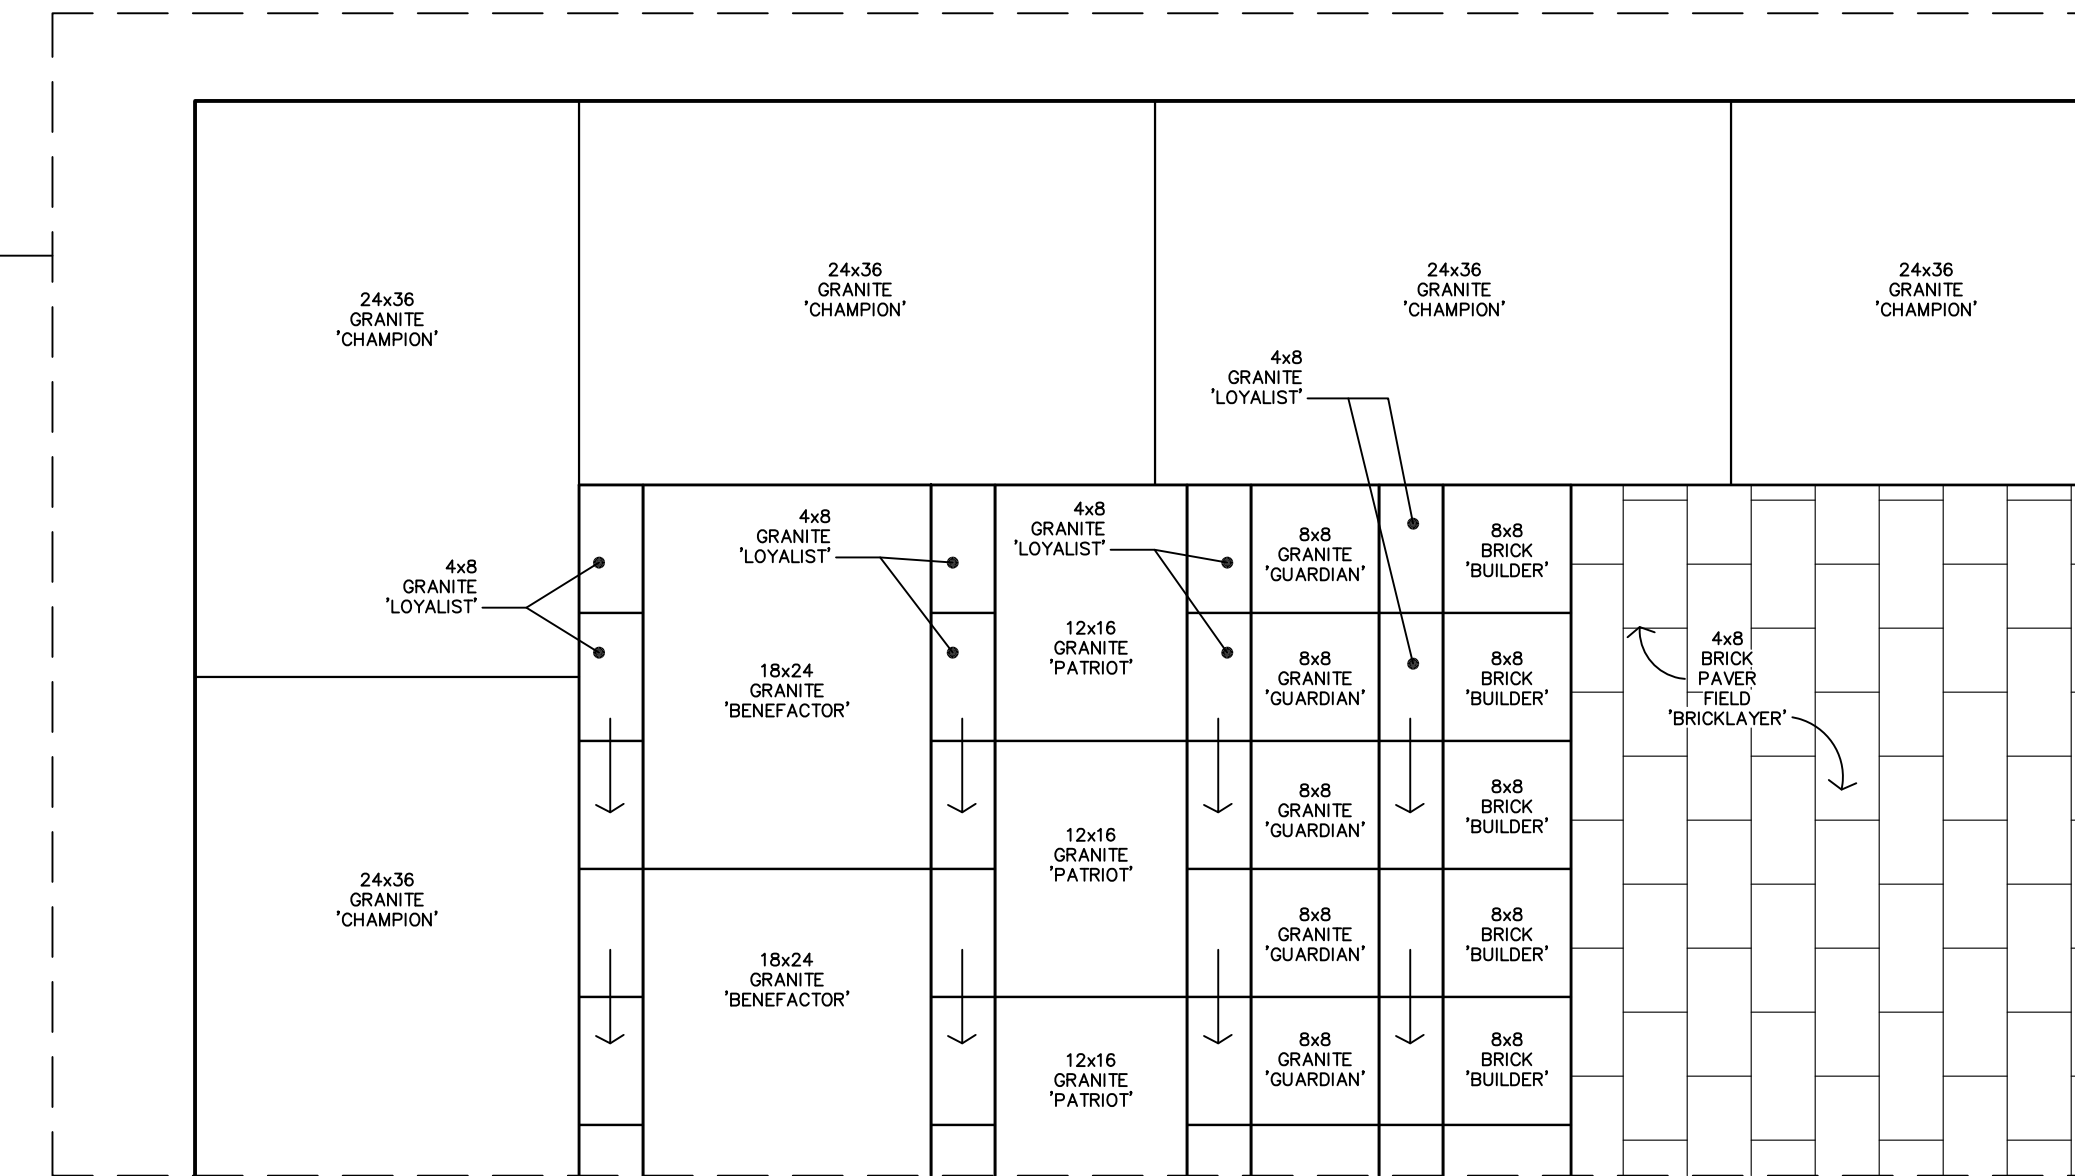

PAVING / WALL MATERIAL LIST:

WALL BRICK MATERIAL:
FACE BRICK – ENGINEER MODULAR SIZE
EBONY SATIN COLOR
SIOUX CITY BRICK

OUTER EDGE – CHAMPION LEVEL:
GRANITE TO MATCH INTERIOR PAVERS
24"x36"x2" ASHFORD WHITE COLOR
HANOVER ARCHITECTURAL PRODUCTS

LANDSCAPE EDGE – BENEFACTOR LEVEL:
GRANITE TO MATCH INTERIOR PAVERS
18"x24"x2" ASHFORD WHITE COLOR
HANOVER ARCHITECTURAL PRODUCTS

OUTER PAVER FIELD – PATRIOT LEVEL:
GRANITE TO MATCH INTERIOR PAVERS
12"x16"x2" ASHFORD WHITE COLOR
HANOVER ARCHITECTURAL PRODUCTS

OUTER PAVER FIELD – GUARDIAN LEVEL:
GRANITE TO MATCH INTERIOR PAVERS
8"x8"x2" ASHFORD WHITE COLOR
HANOVER ARCHITECTURAL PRODUCTS

OUTER PAVER FIELD – LOYALIST LEVEL:
GRANITE TO MATCH INTERIOR PAVERS
4"x8"x2" ASHFORD WHITE COLOR
HANOVER ARCHITECTURAL PRODUCTS

OUTER PAVER FIELD – BUILDER LEVEL:
BELDEN BRICK – CITY LINE PAVERS
8"x8"x2 1/4" -- REGIMENTAL RED

PAVER FIELD – BRICKLAYER LEVEL and REMAINING FIELD:
BELDEN BRICK – CITY LINE PAVERS
4"x8"x2 1/4" -- REGIMENTAL RED

FLAG POLE SPECS:


<http://www.eaglemountainflag.com>

EAGLE MOUNTAIN FLAG and FLAGPOLE
FLAG POLE INSTALLED

FLAGPOLE LIGHT: 1 (ONE) REQUIRED
IN-GROUND LIGHT SERIES:
MODEL NUMBER: IGCMLGT01-HD
WALK OVER LENS
CONCRETE POUR KIT


**EAGLE SCULPTURE
MEMORIAL PLAQUES**

ITEMS TO BE INSTALLED OUTSIDE OF CONTRACT

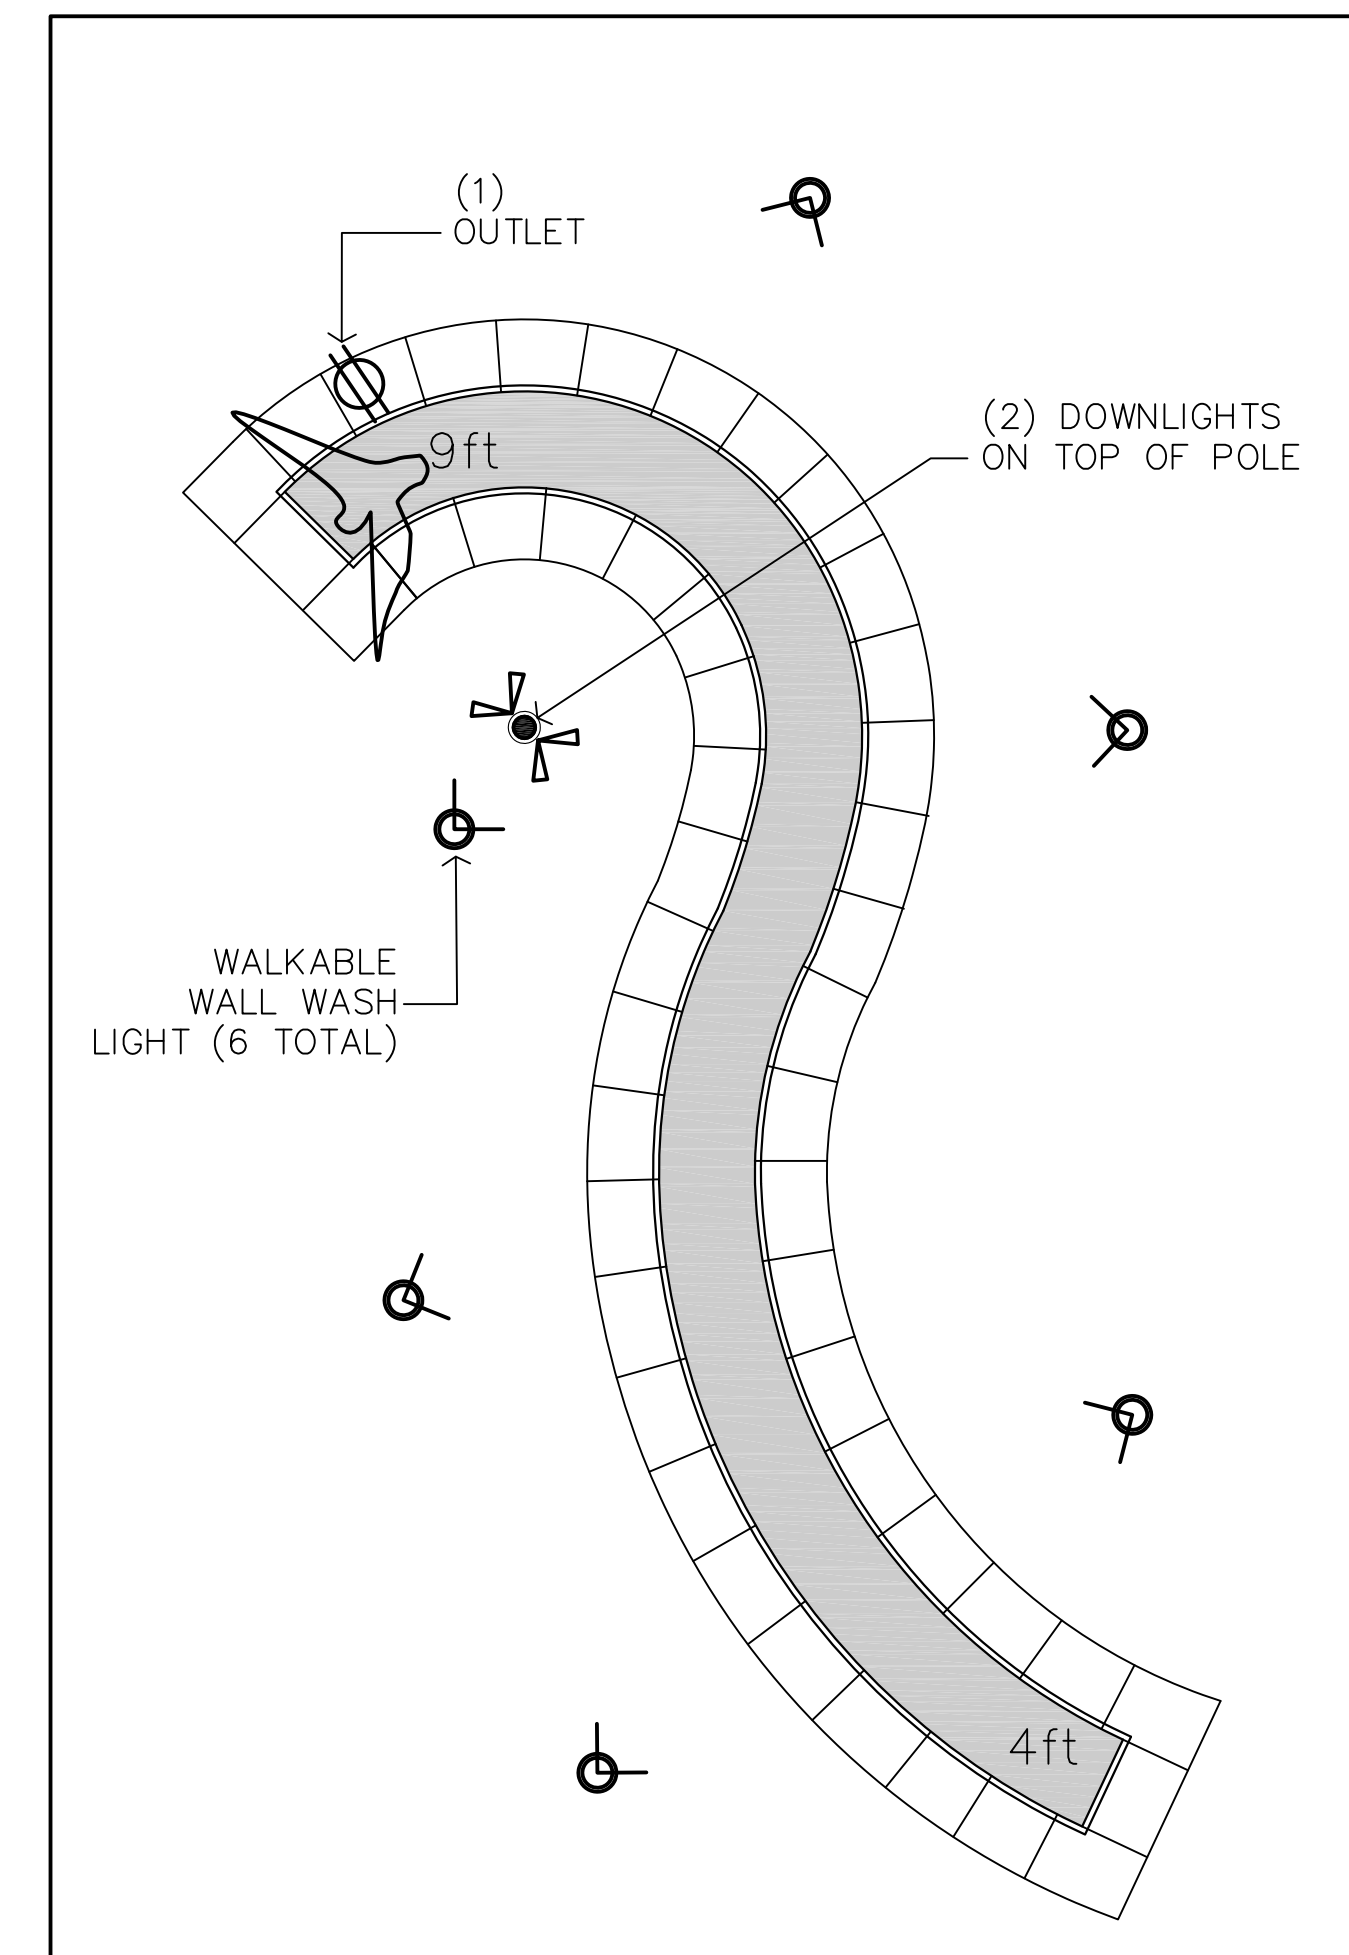

LIGHTING LAYOUT
SCALE: 1/4" = 1'-0"


323 SOUTH YORK ROAD
HATBORO, PA 19040
TEL 215.442.1780
FAX 215.442.1781
THEOMNIAGROUP.COM

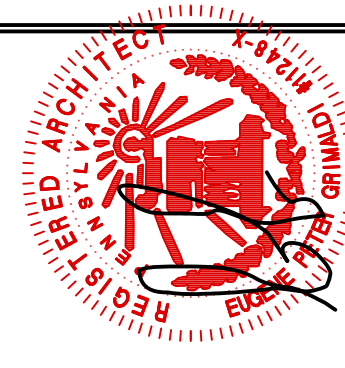


The Lower Makefield Veterans Monument
Veterans Square Foundation
Corner of Heacock and Edgewood Rd, Yardley PA

DRAWING DATE	03/26/14
REVISION DATES	

A-1

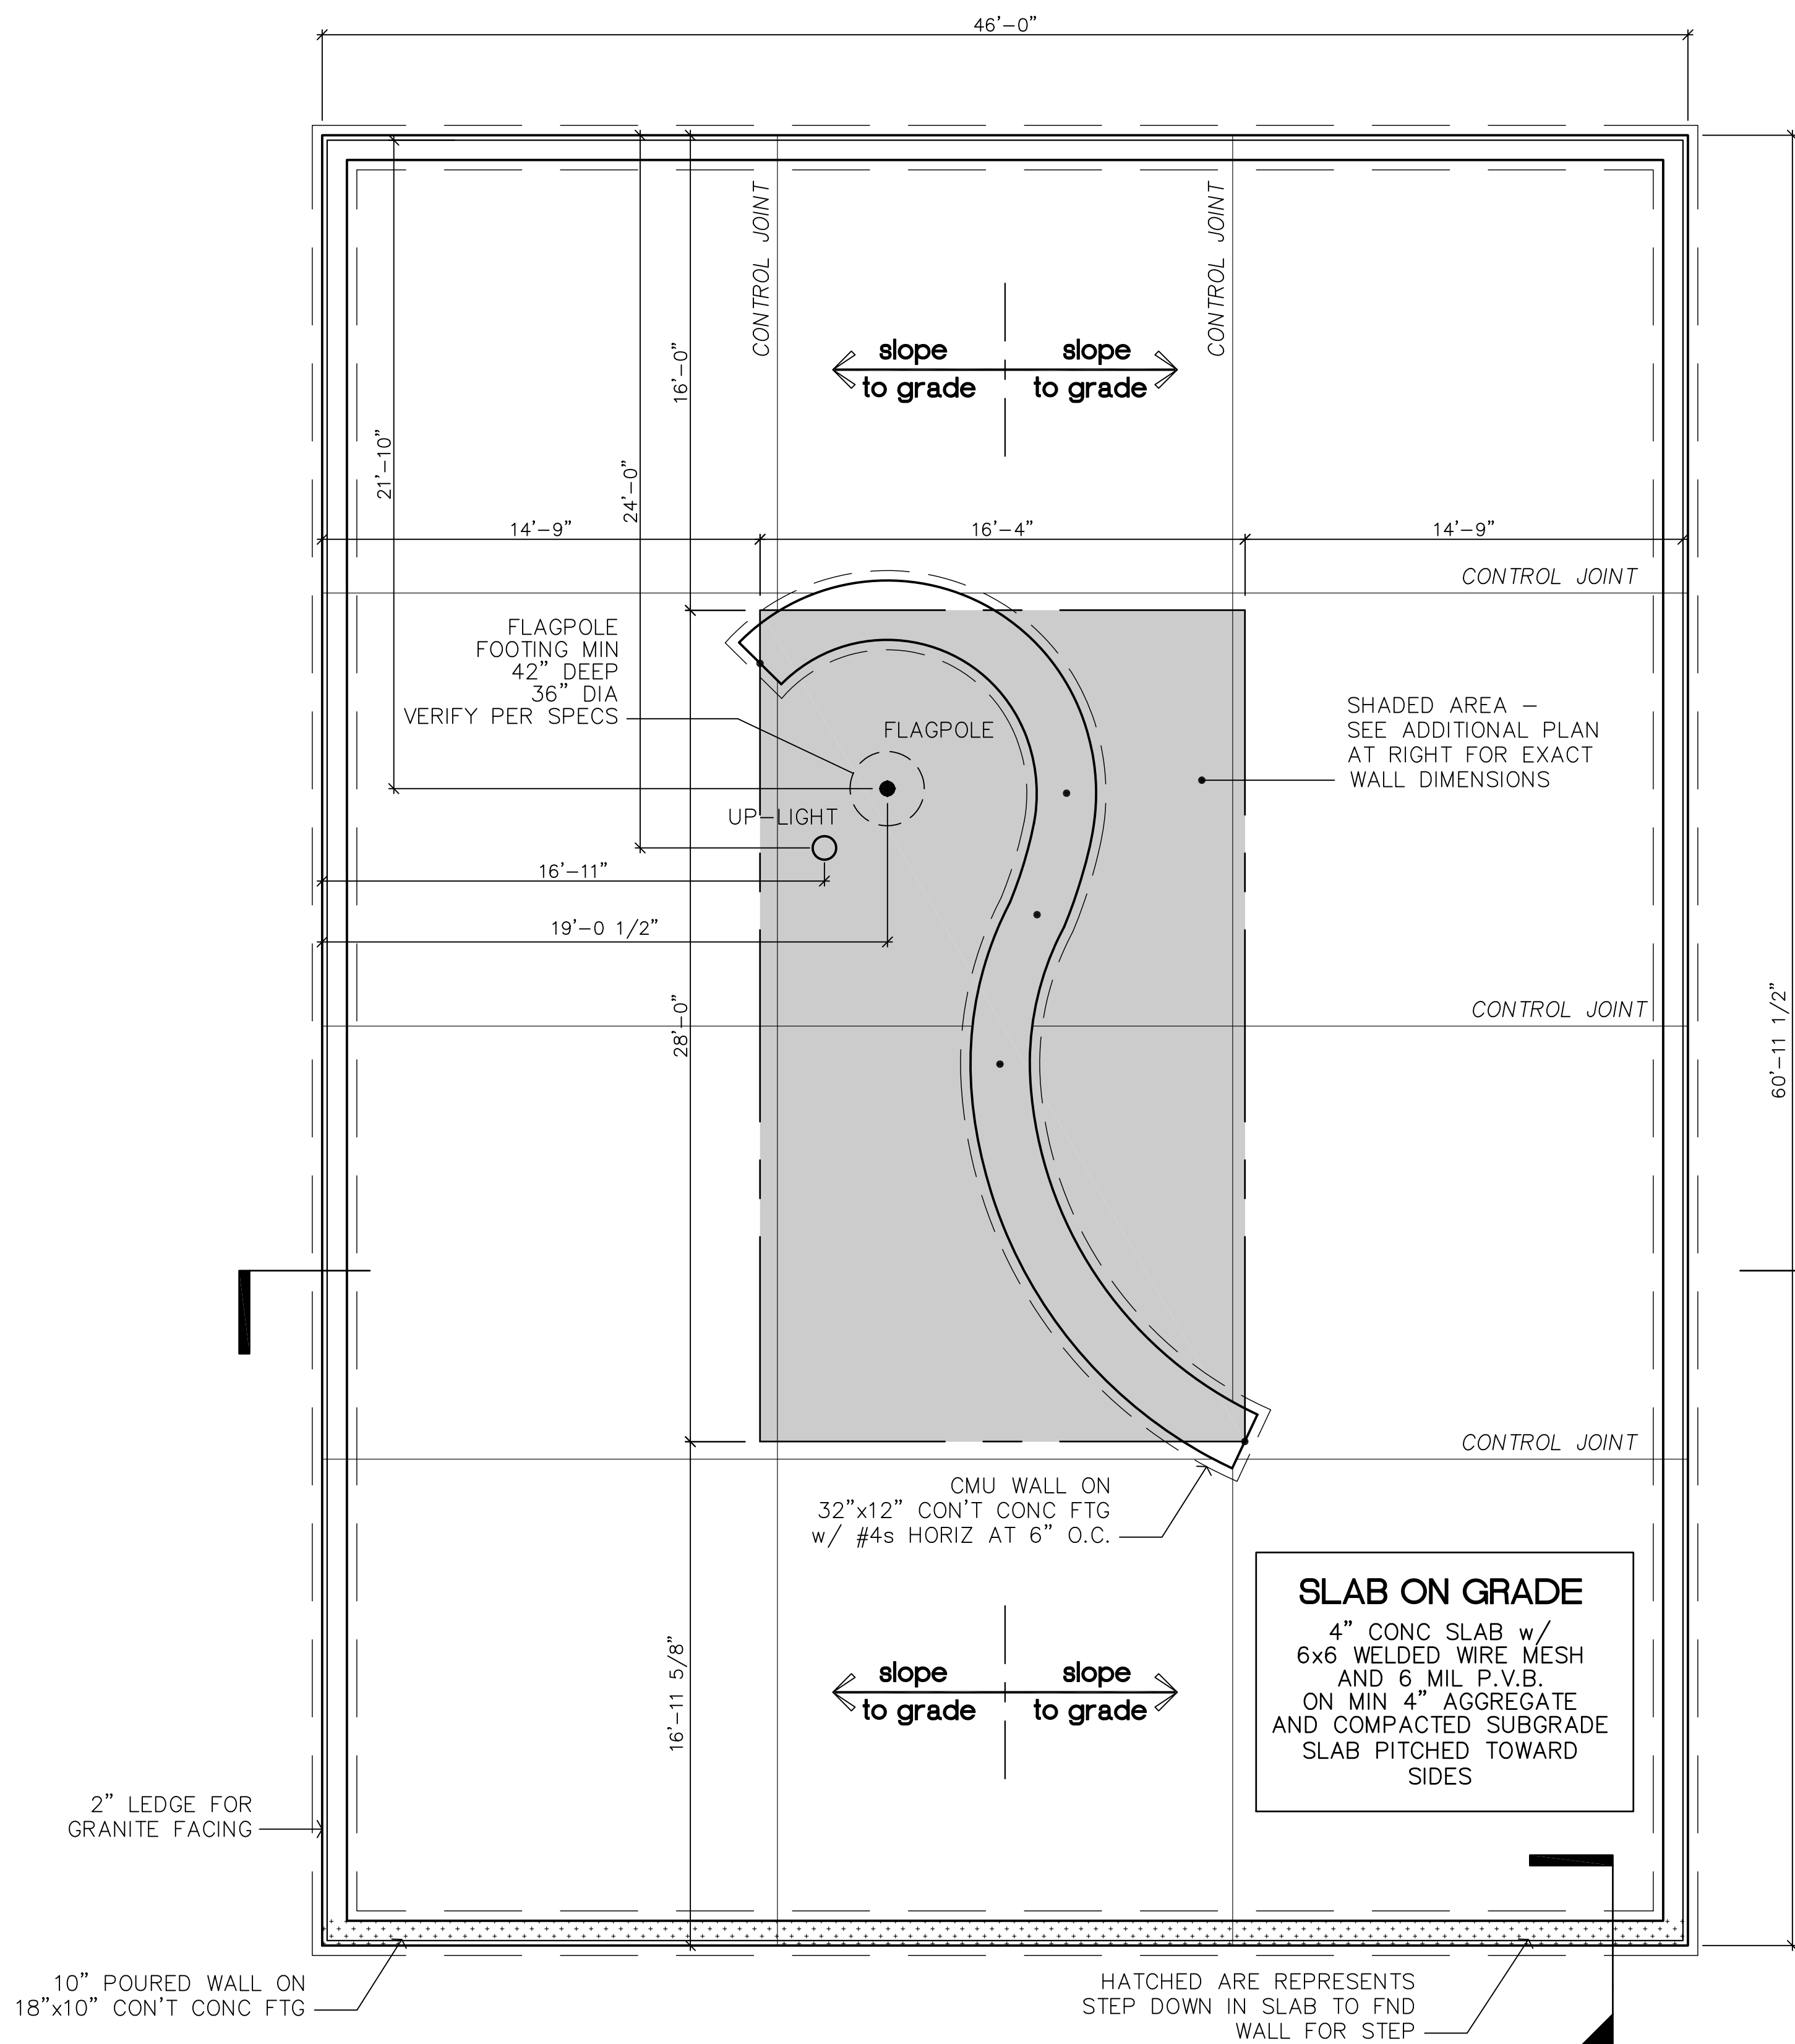

FOUNDATION / SLAB ON GRADE PLAN
SCALE: 1/4" = 1'-0"

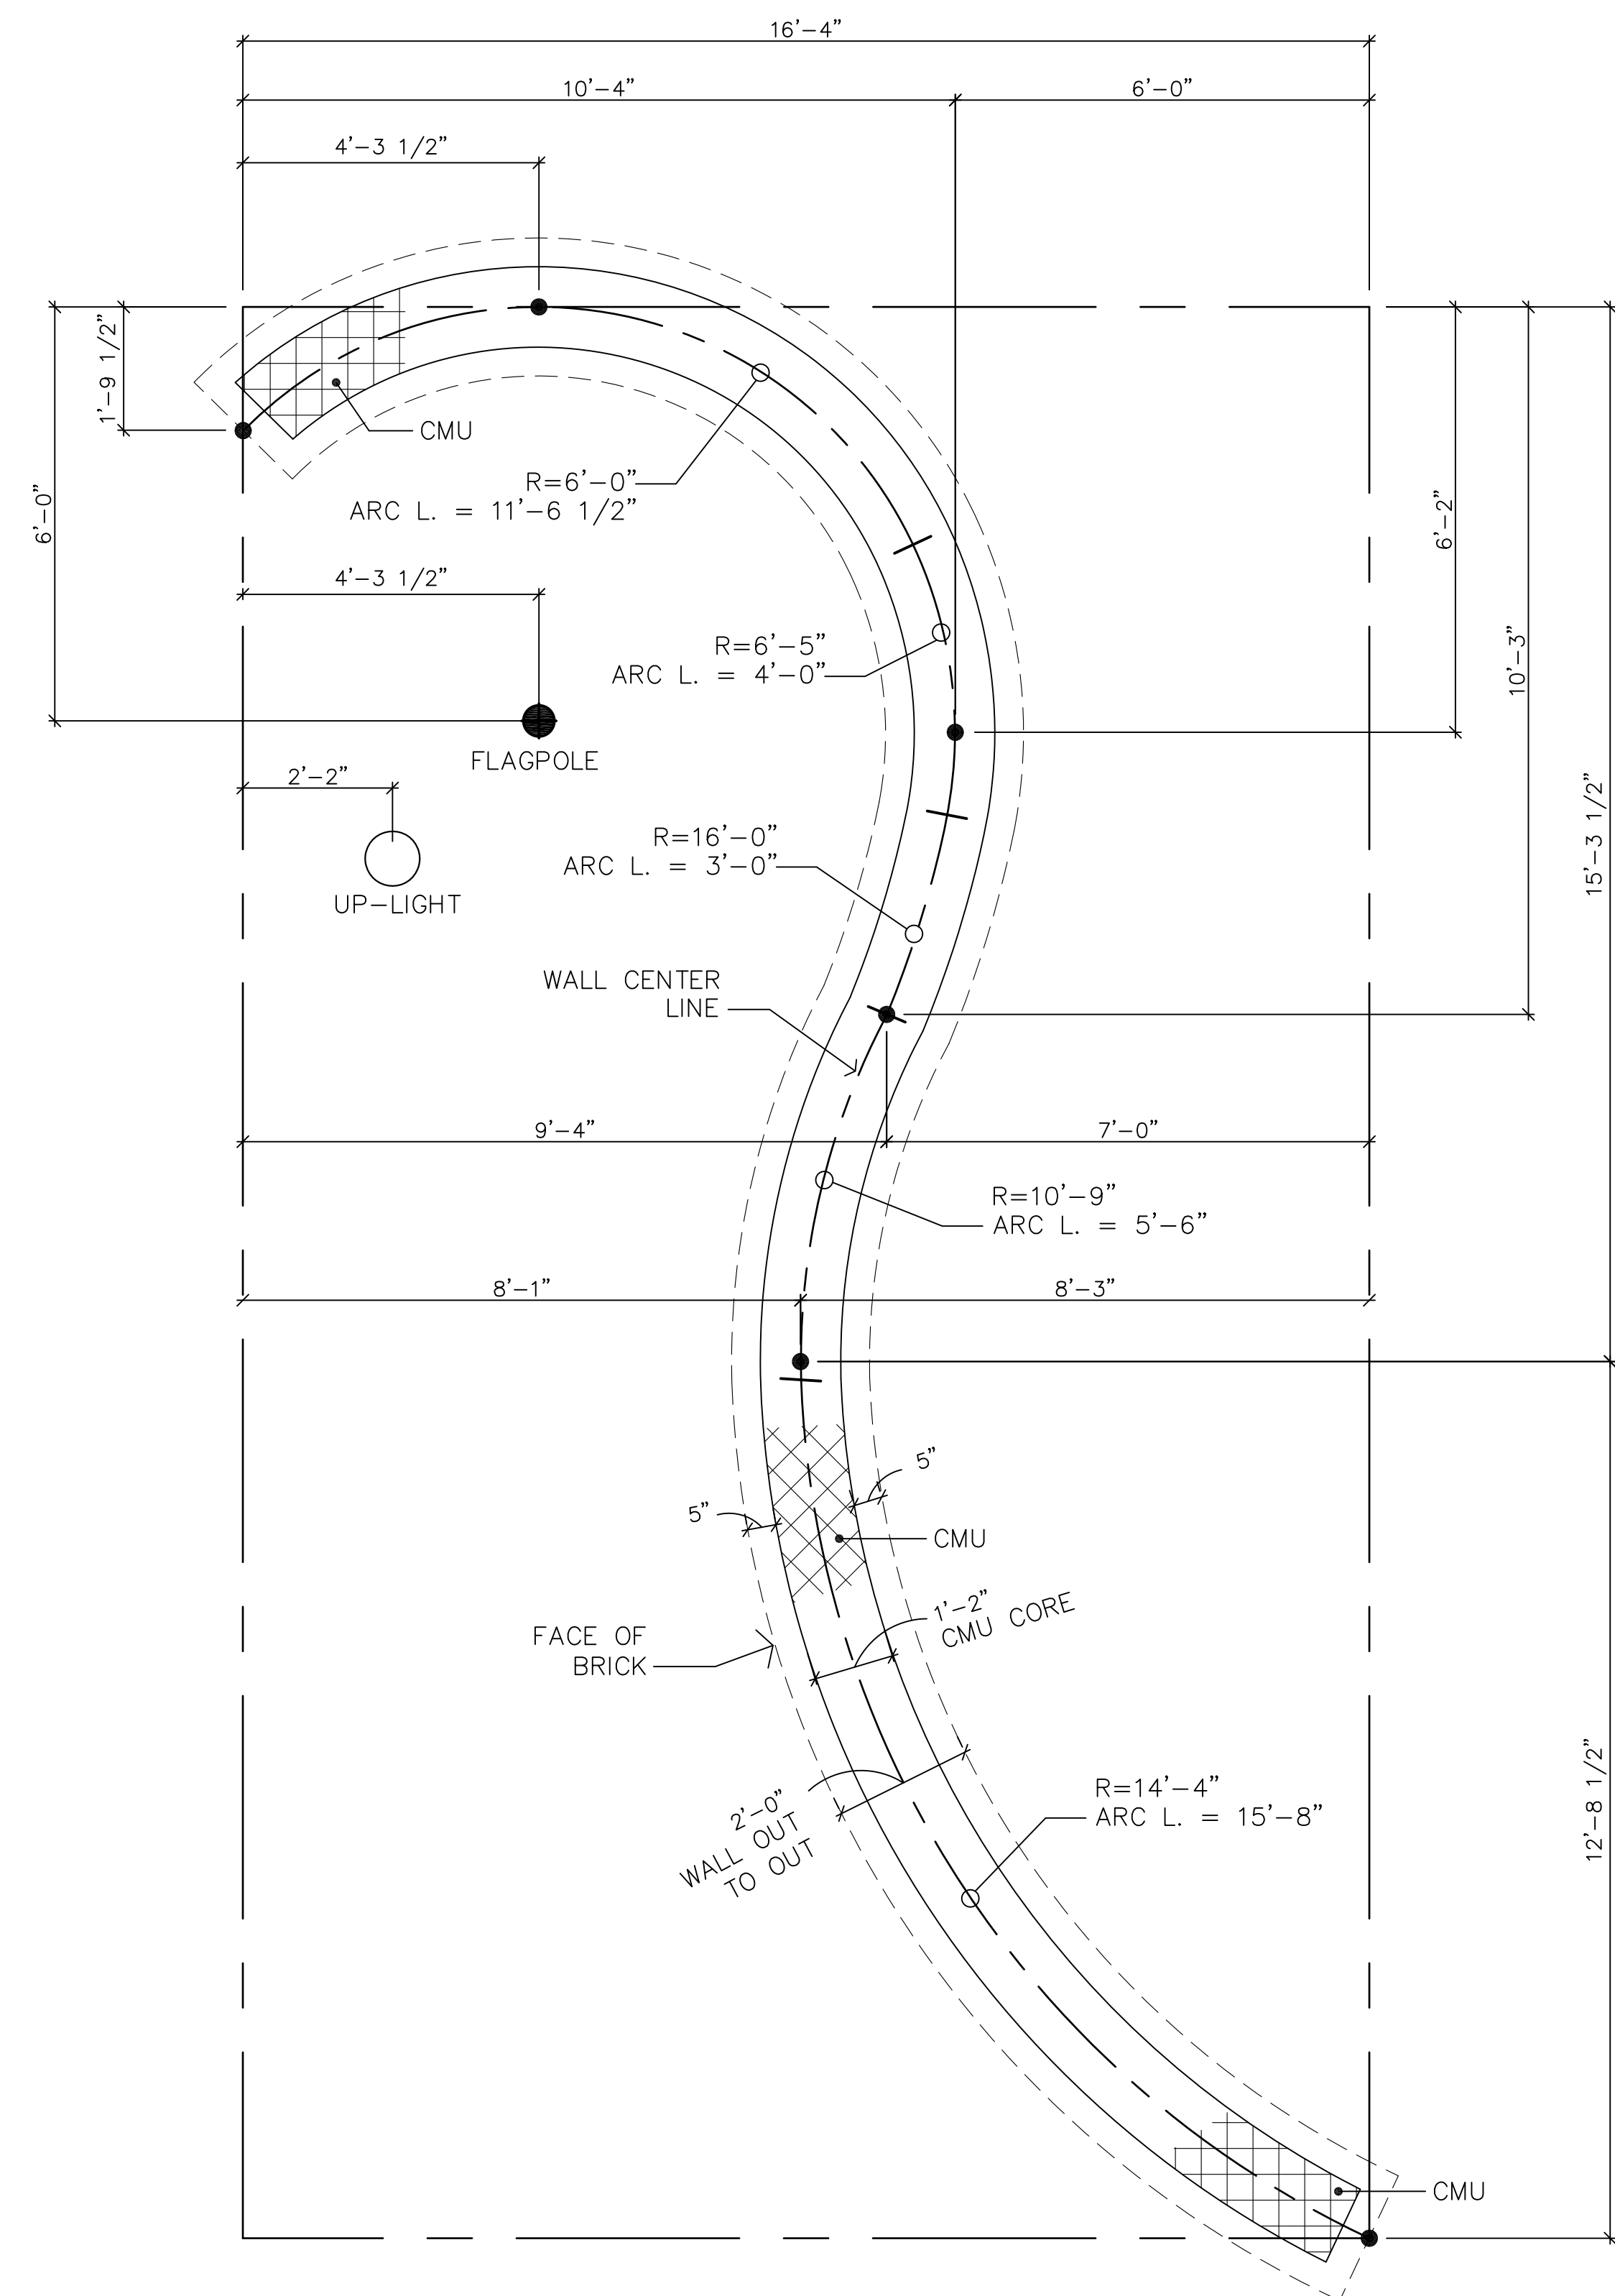

WALL DIMENSIONS
SCALE: 1/2" = 1'-0"



323 SOUTH YORK ROAD
HATBORO, PA 19040
TEL 215.442.1780
FAX 215.442.1781
THEOMNIAGROUP.COM
THEOMNIARCHITECTS



The Lower Makefield Veteran's Monument
Veterans Square Foundation
Corner of Heacock and Edgewood Rd, Yardley PA

DRAWING DATE
03/26/14
REVISION DATES

A-2

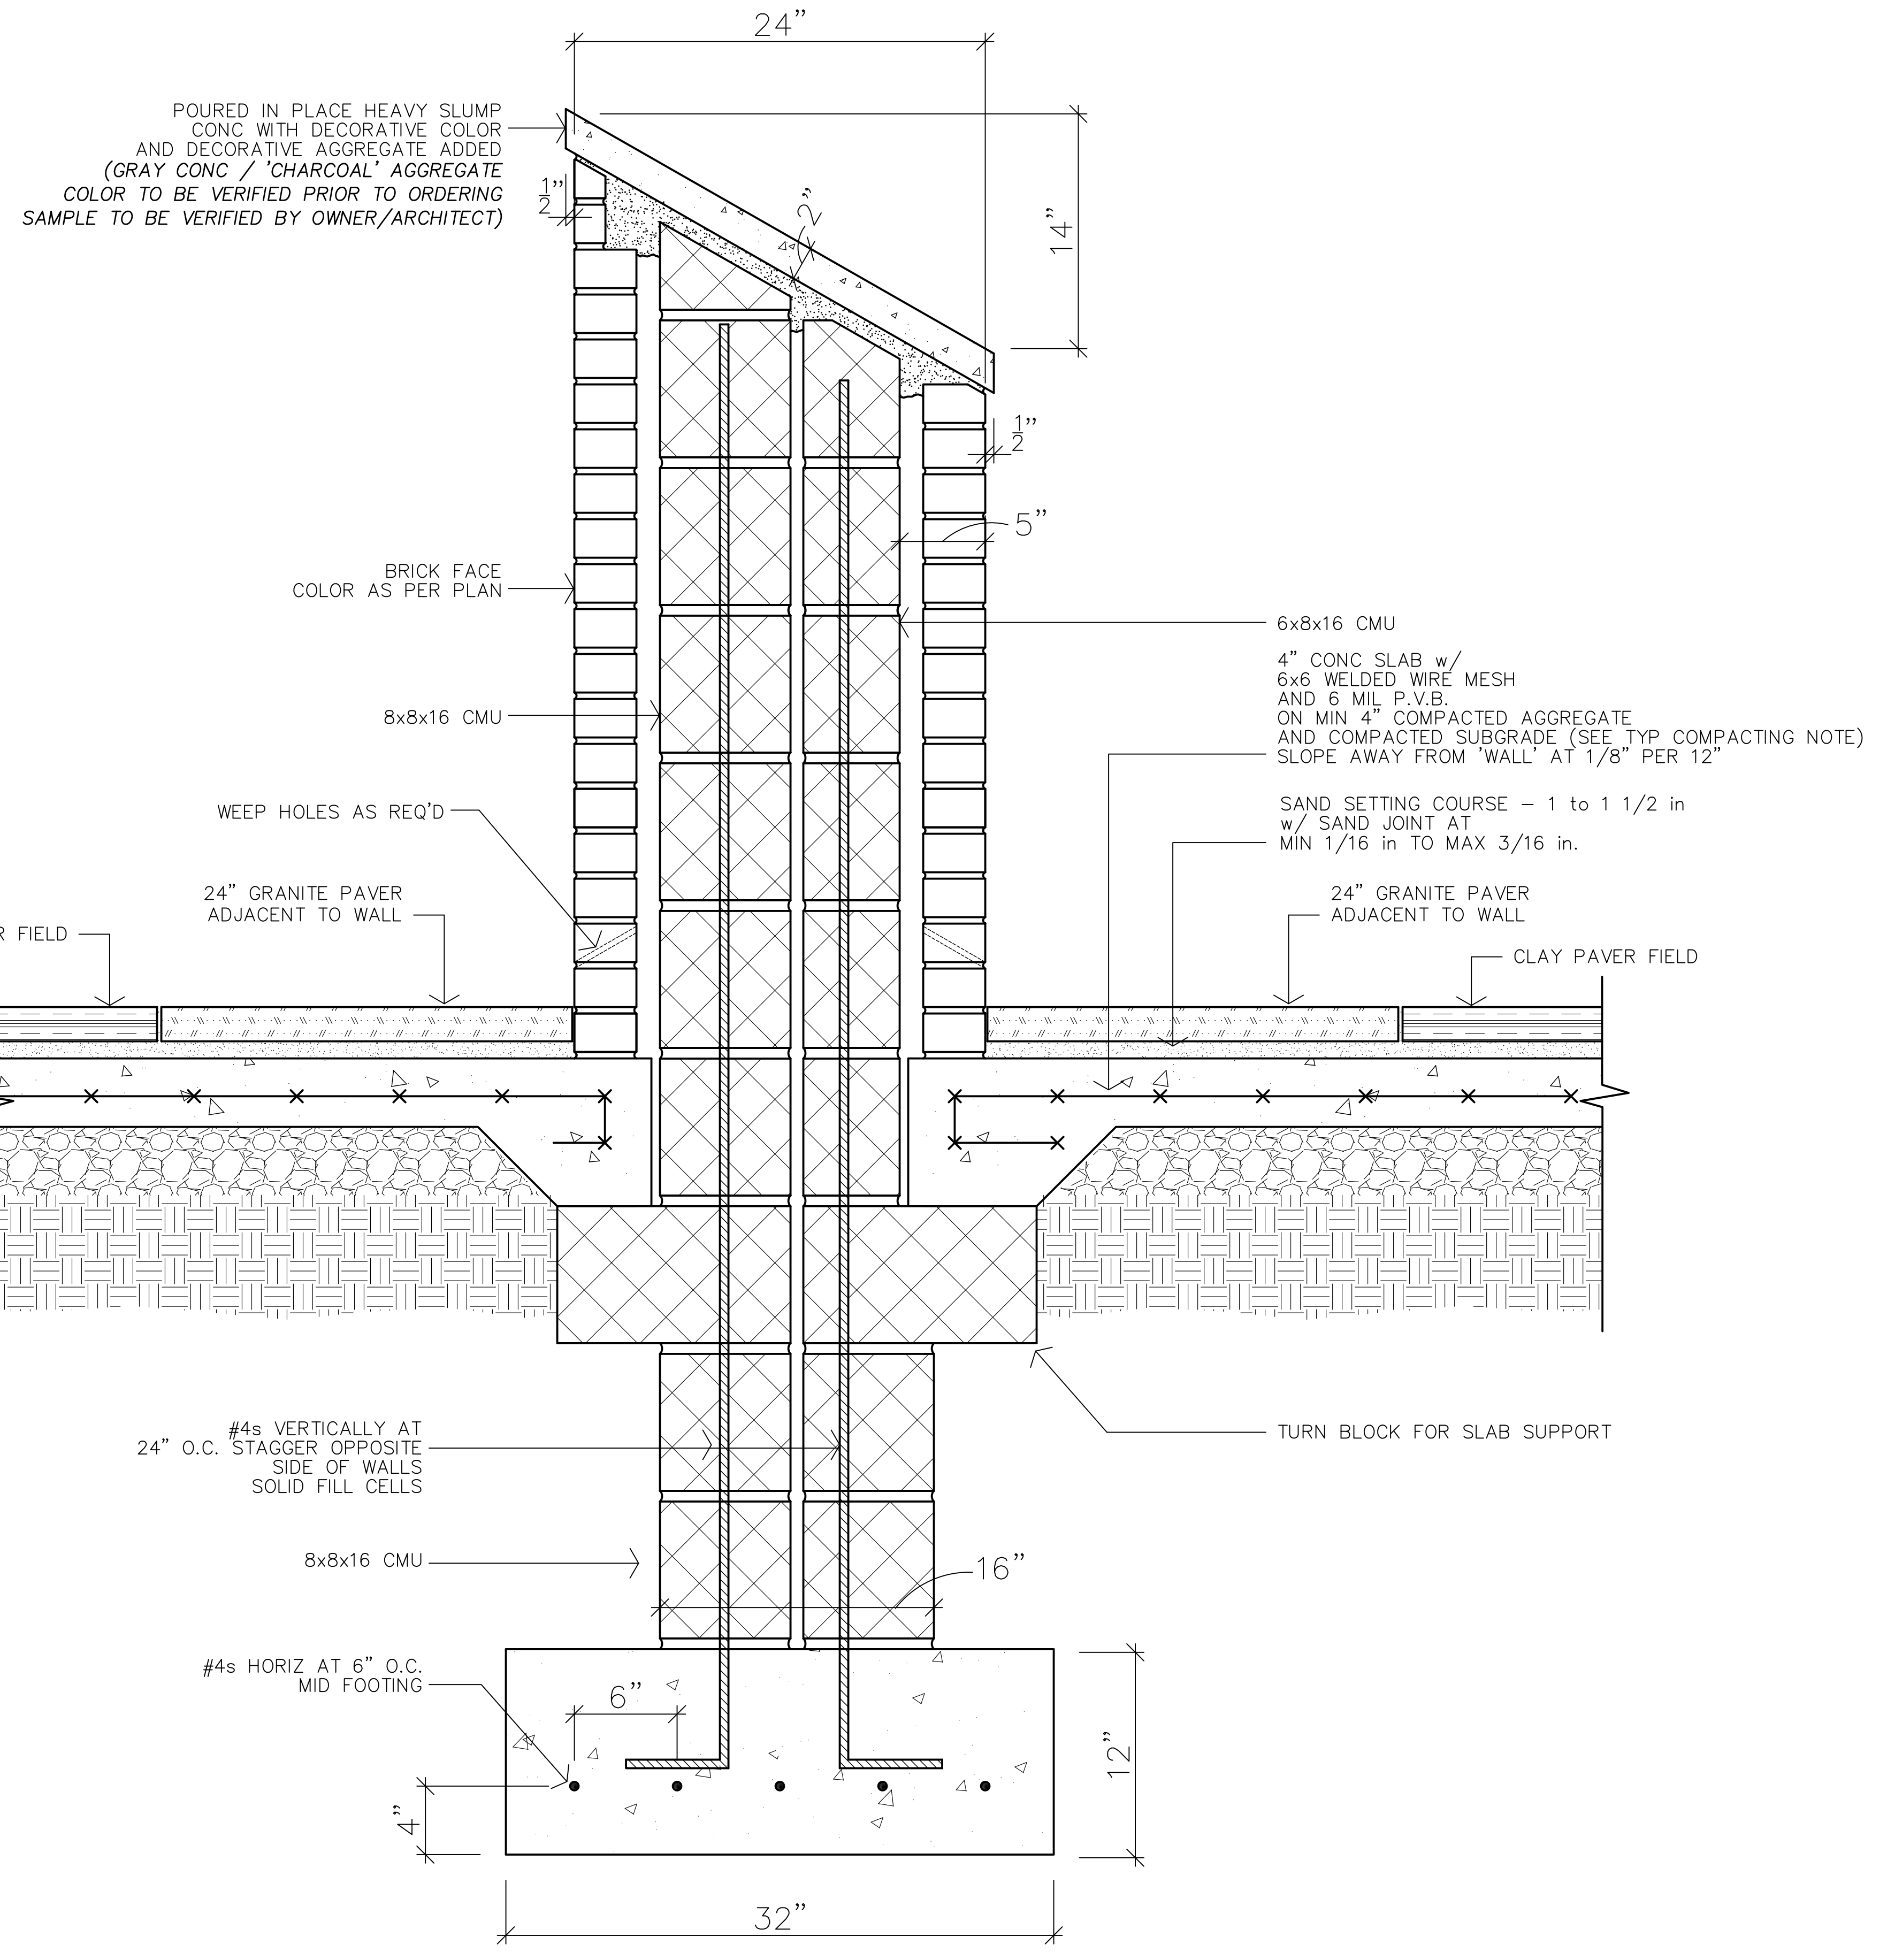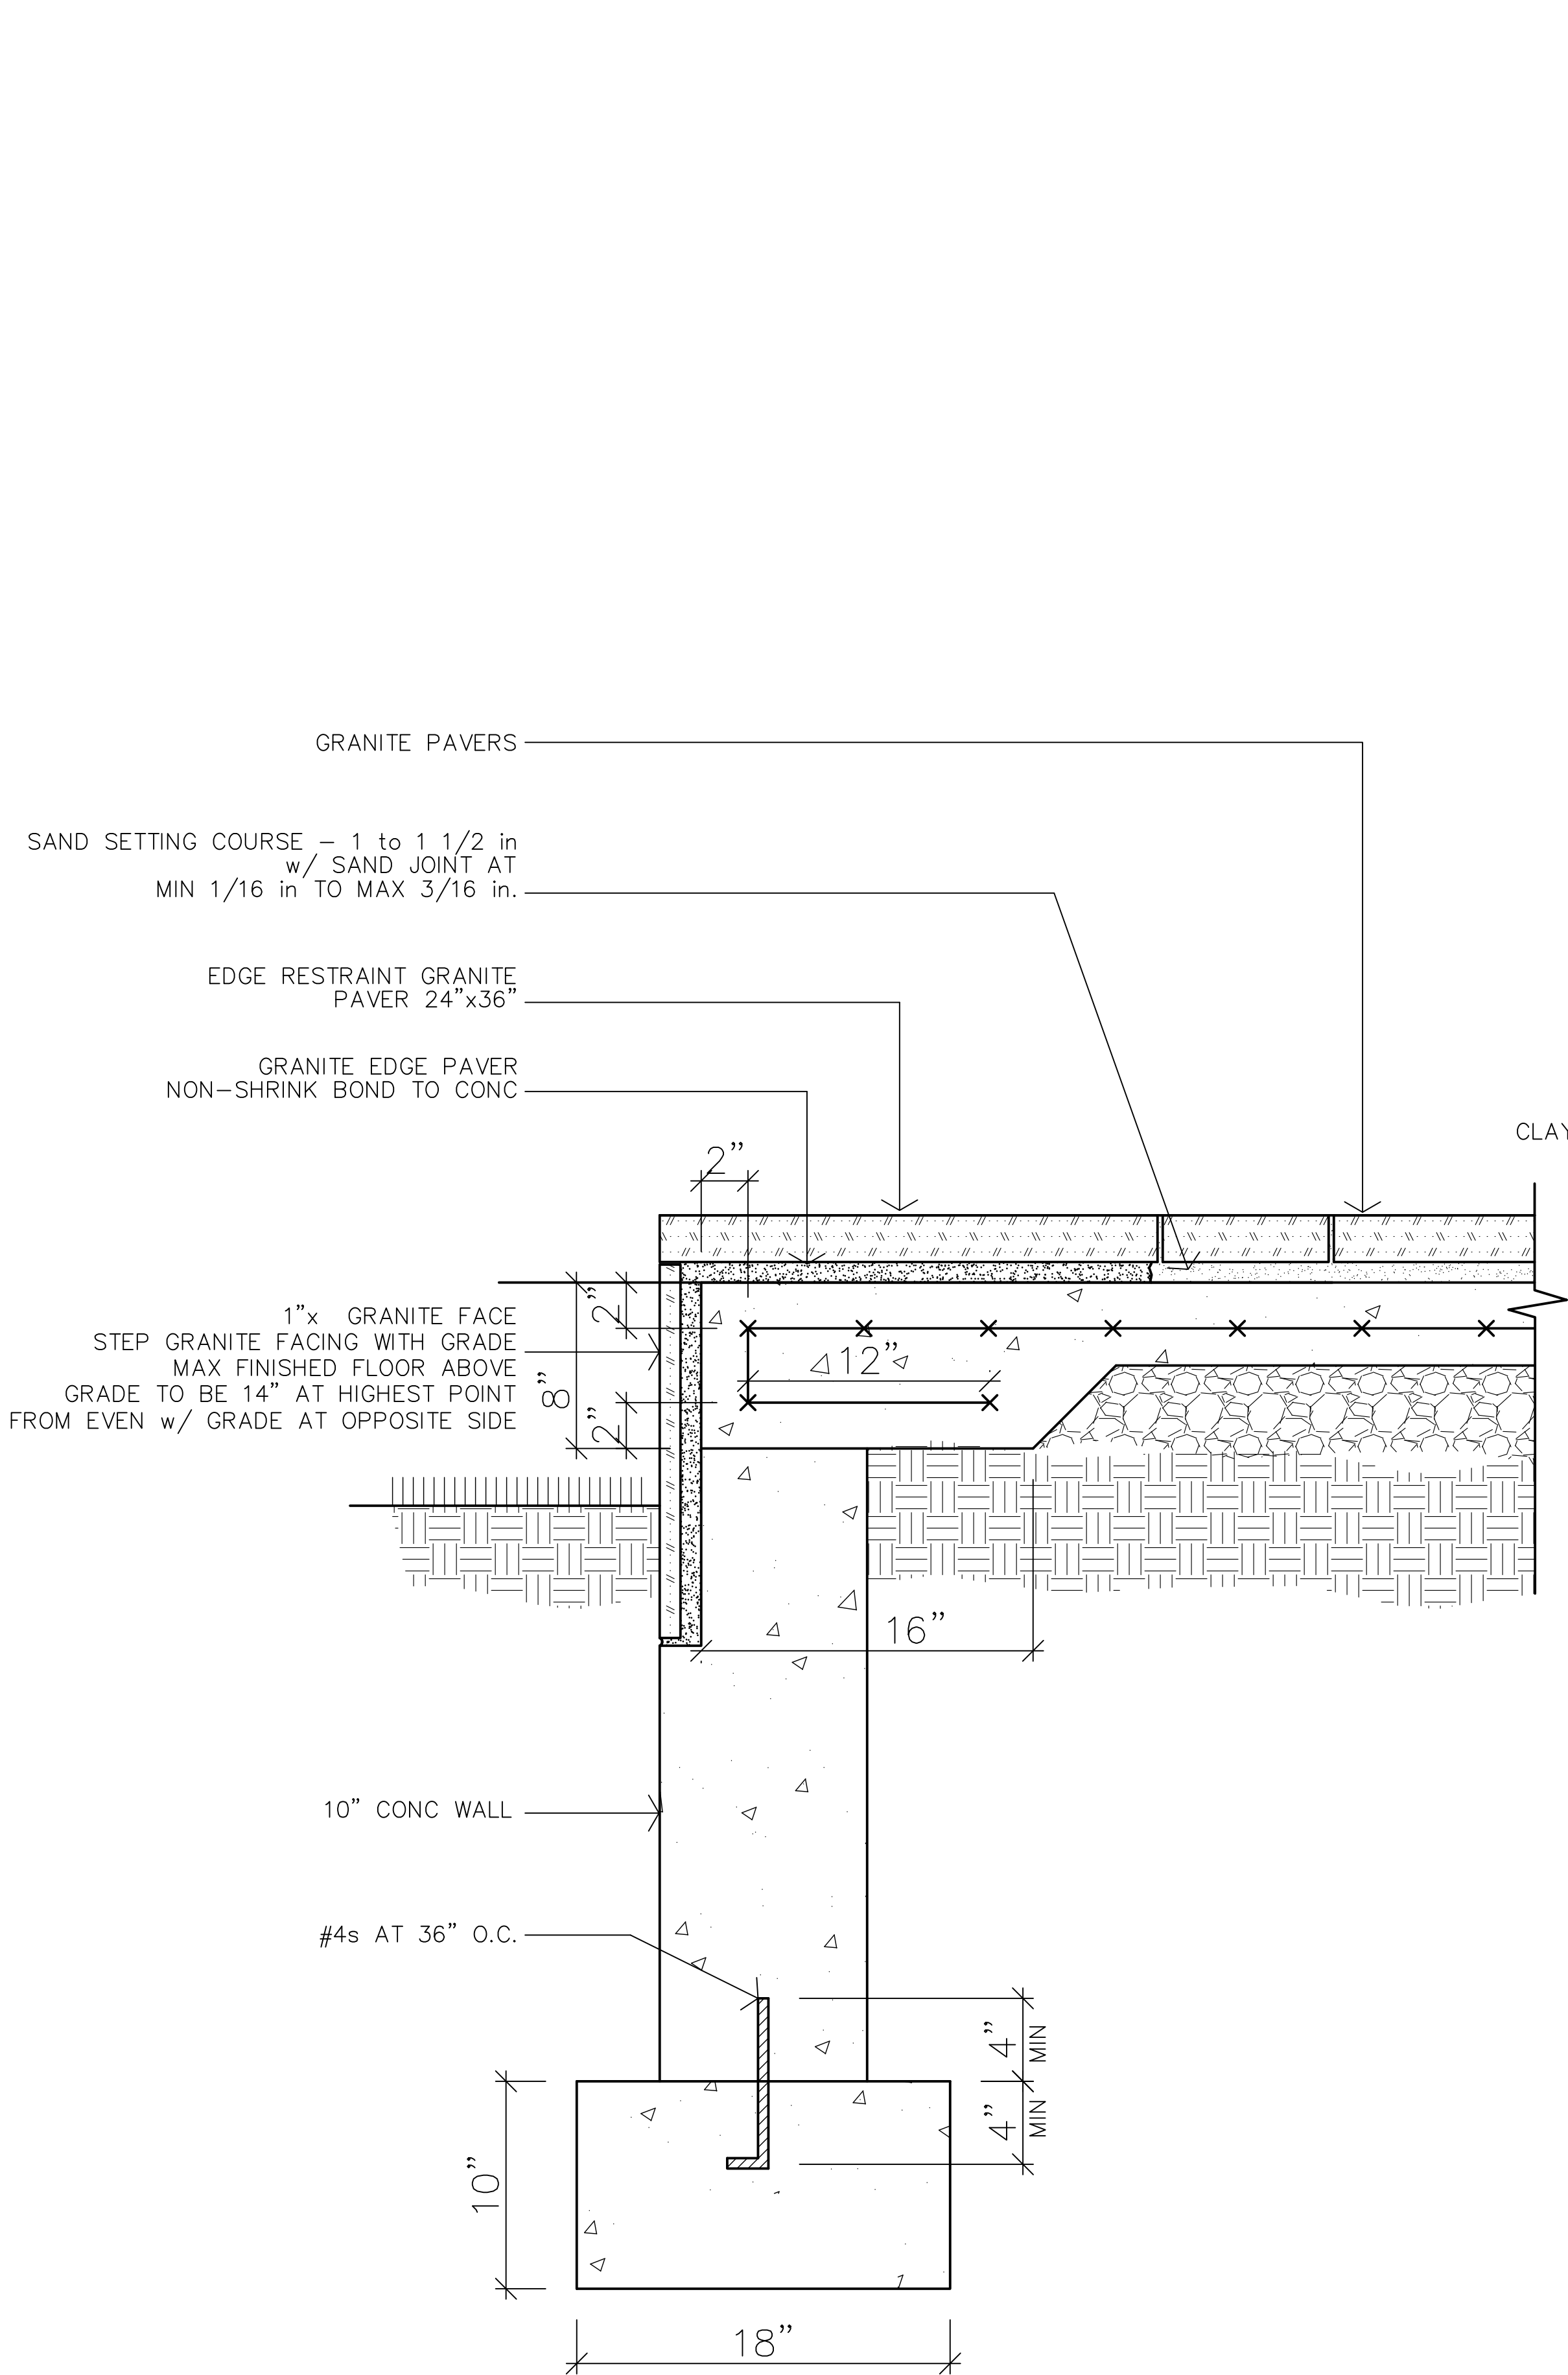


SECTION
SCALE: 2" = 1'-0"

323 SOUTH YORK ROAD
HATBORO, PA 19040
TEL 215.442.1780
FAX 215.442.1781
THEOMNIAGROUP.COM
THEOMNIARCHITECTS



The Lower Makefield Veteran's Monument
Veterans Square Foundation
Corner of Heacock and Edgewood Rd, Yardley PA

DRAWING DATE
03/26/14
REVISION DATES

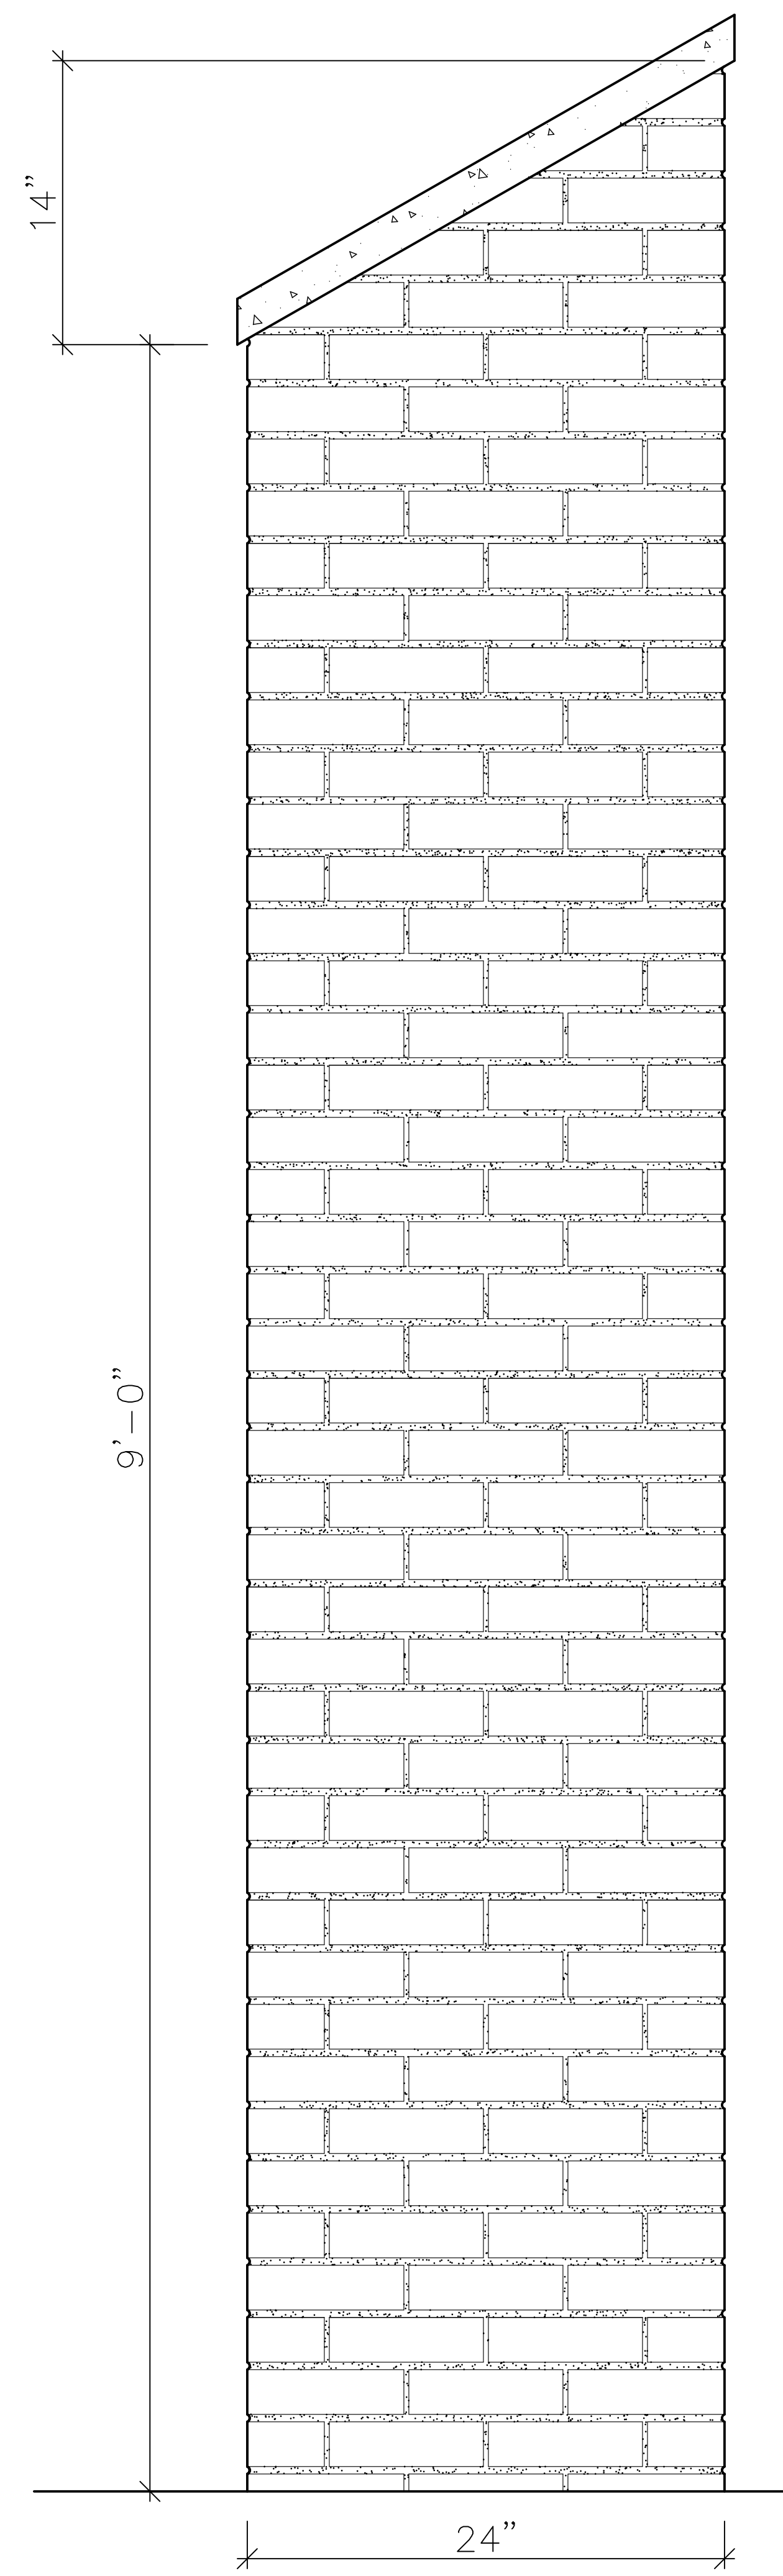


WALL END ELEVATION - HIGH END
SCALE: 2" = 1'-0"




VIEW FROM FRONT / LEFT CORNER



VIEW FROM FRONT / RIGHT SIDE

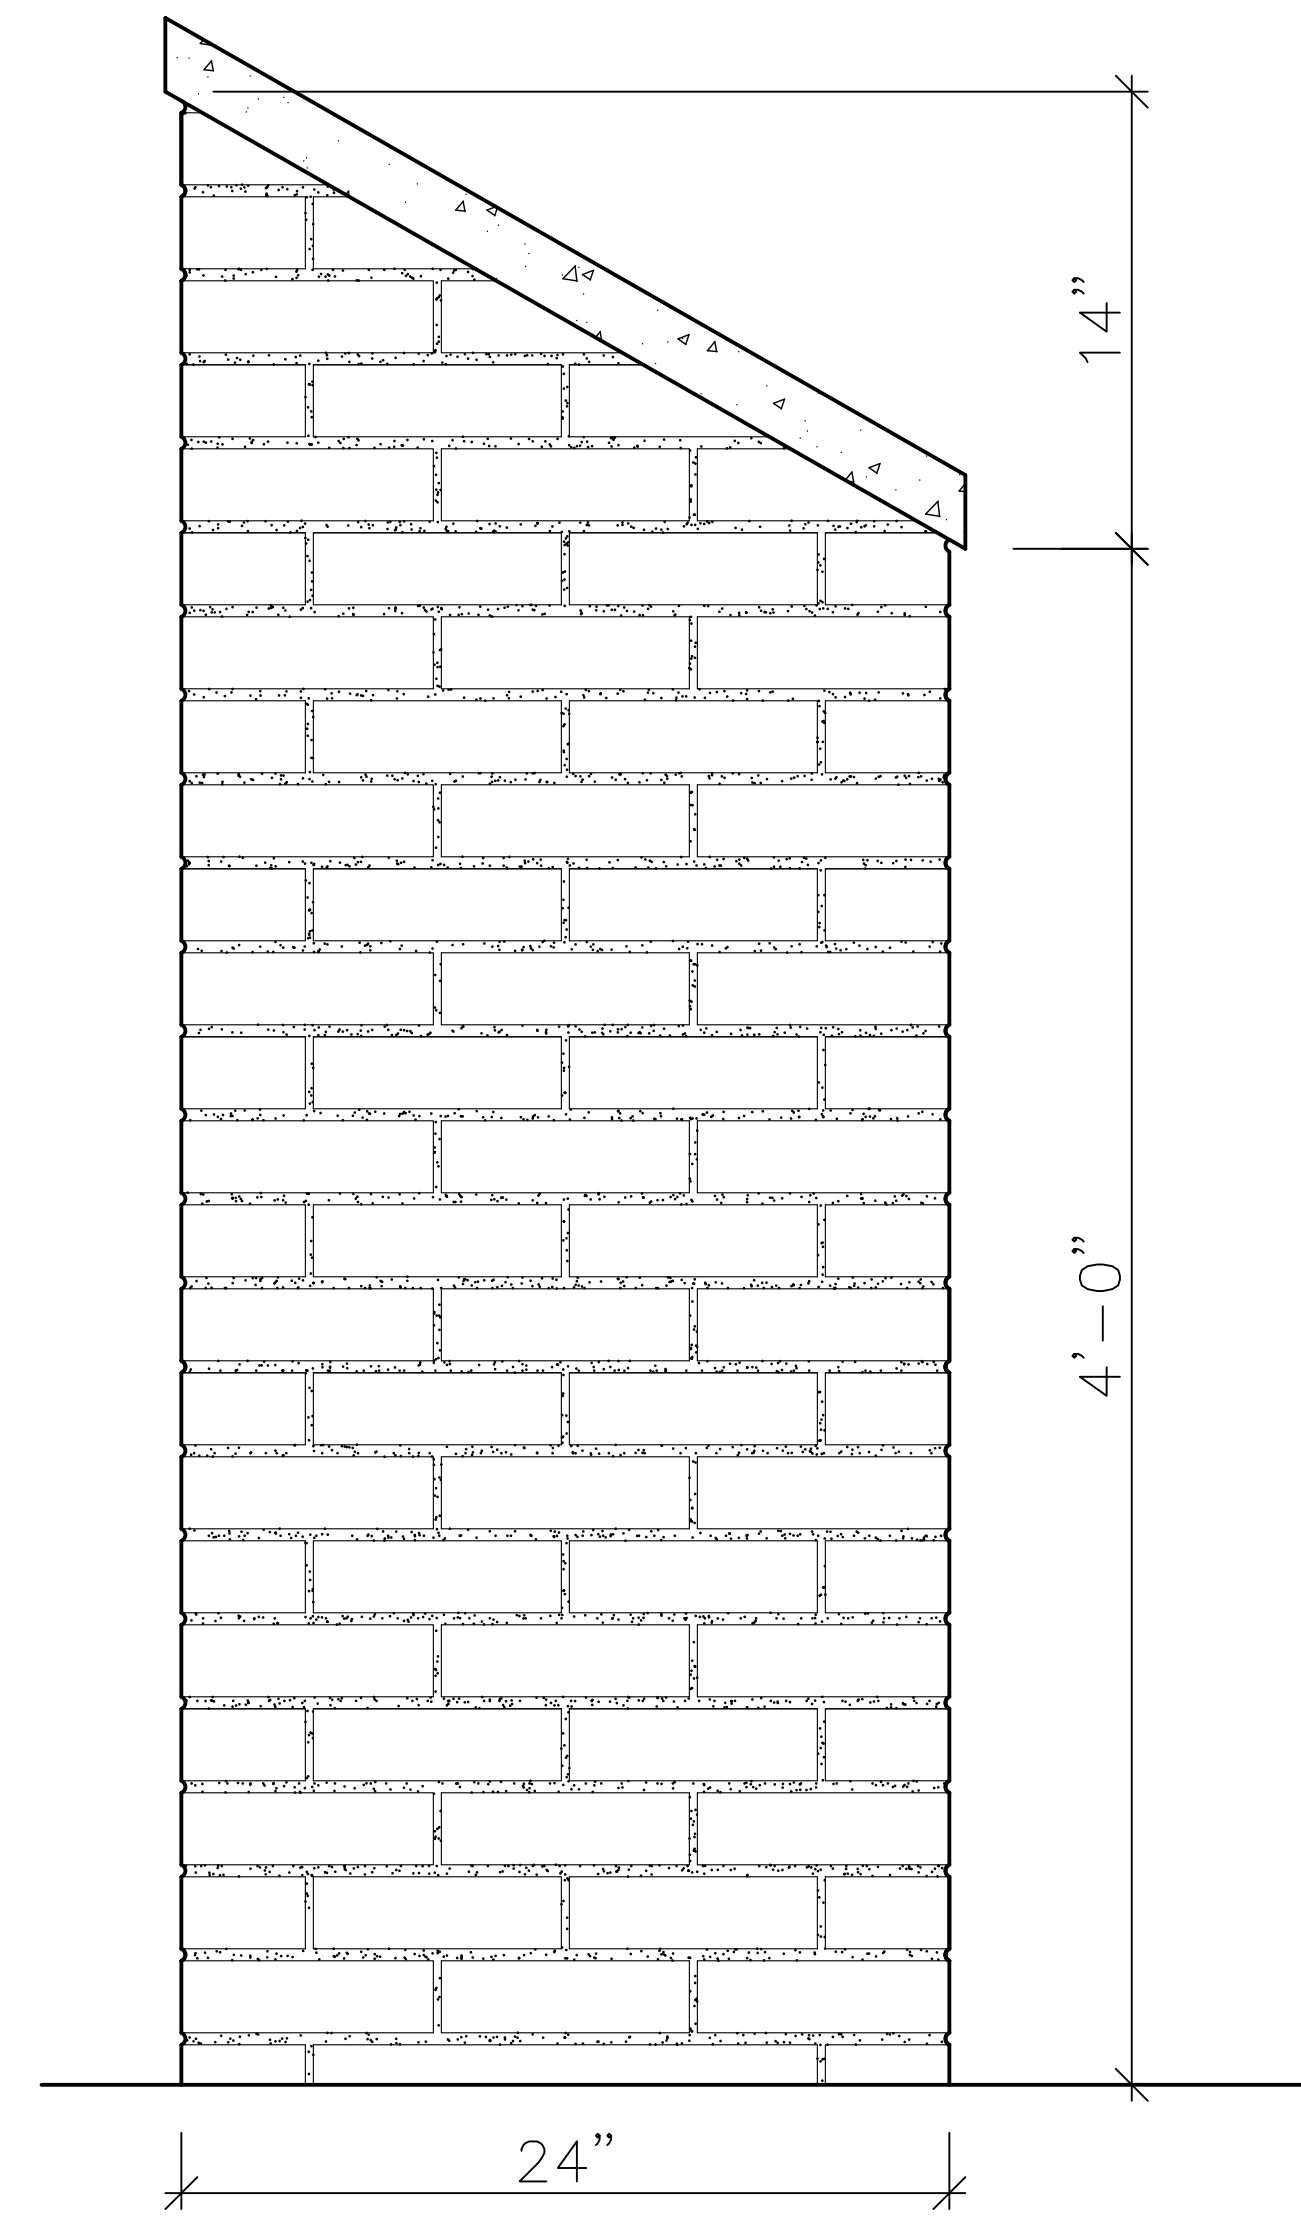


WALL END ELEVATION - LOW START
SCALE: 2" = 1'-0"

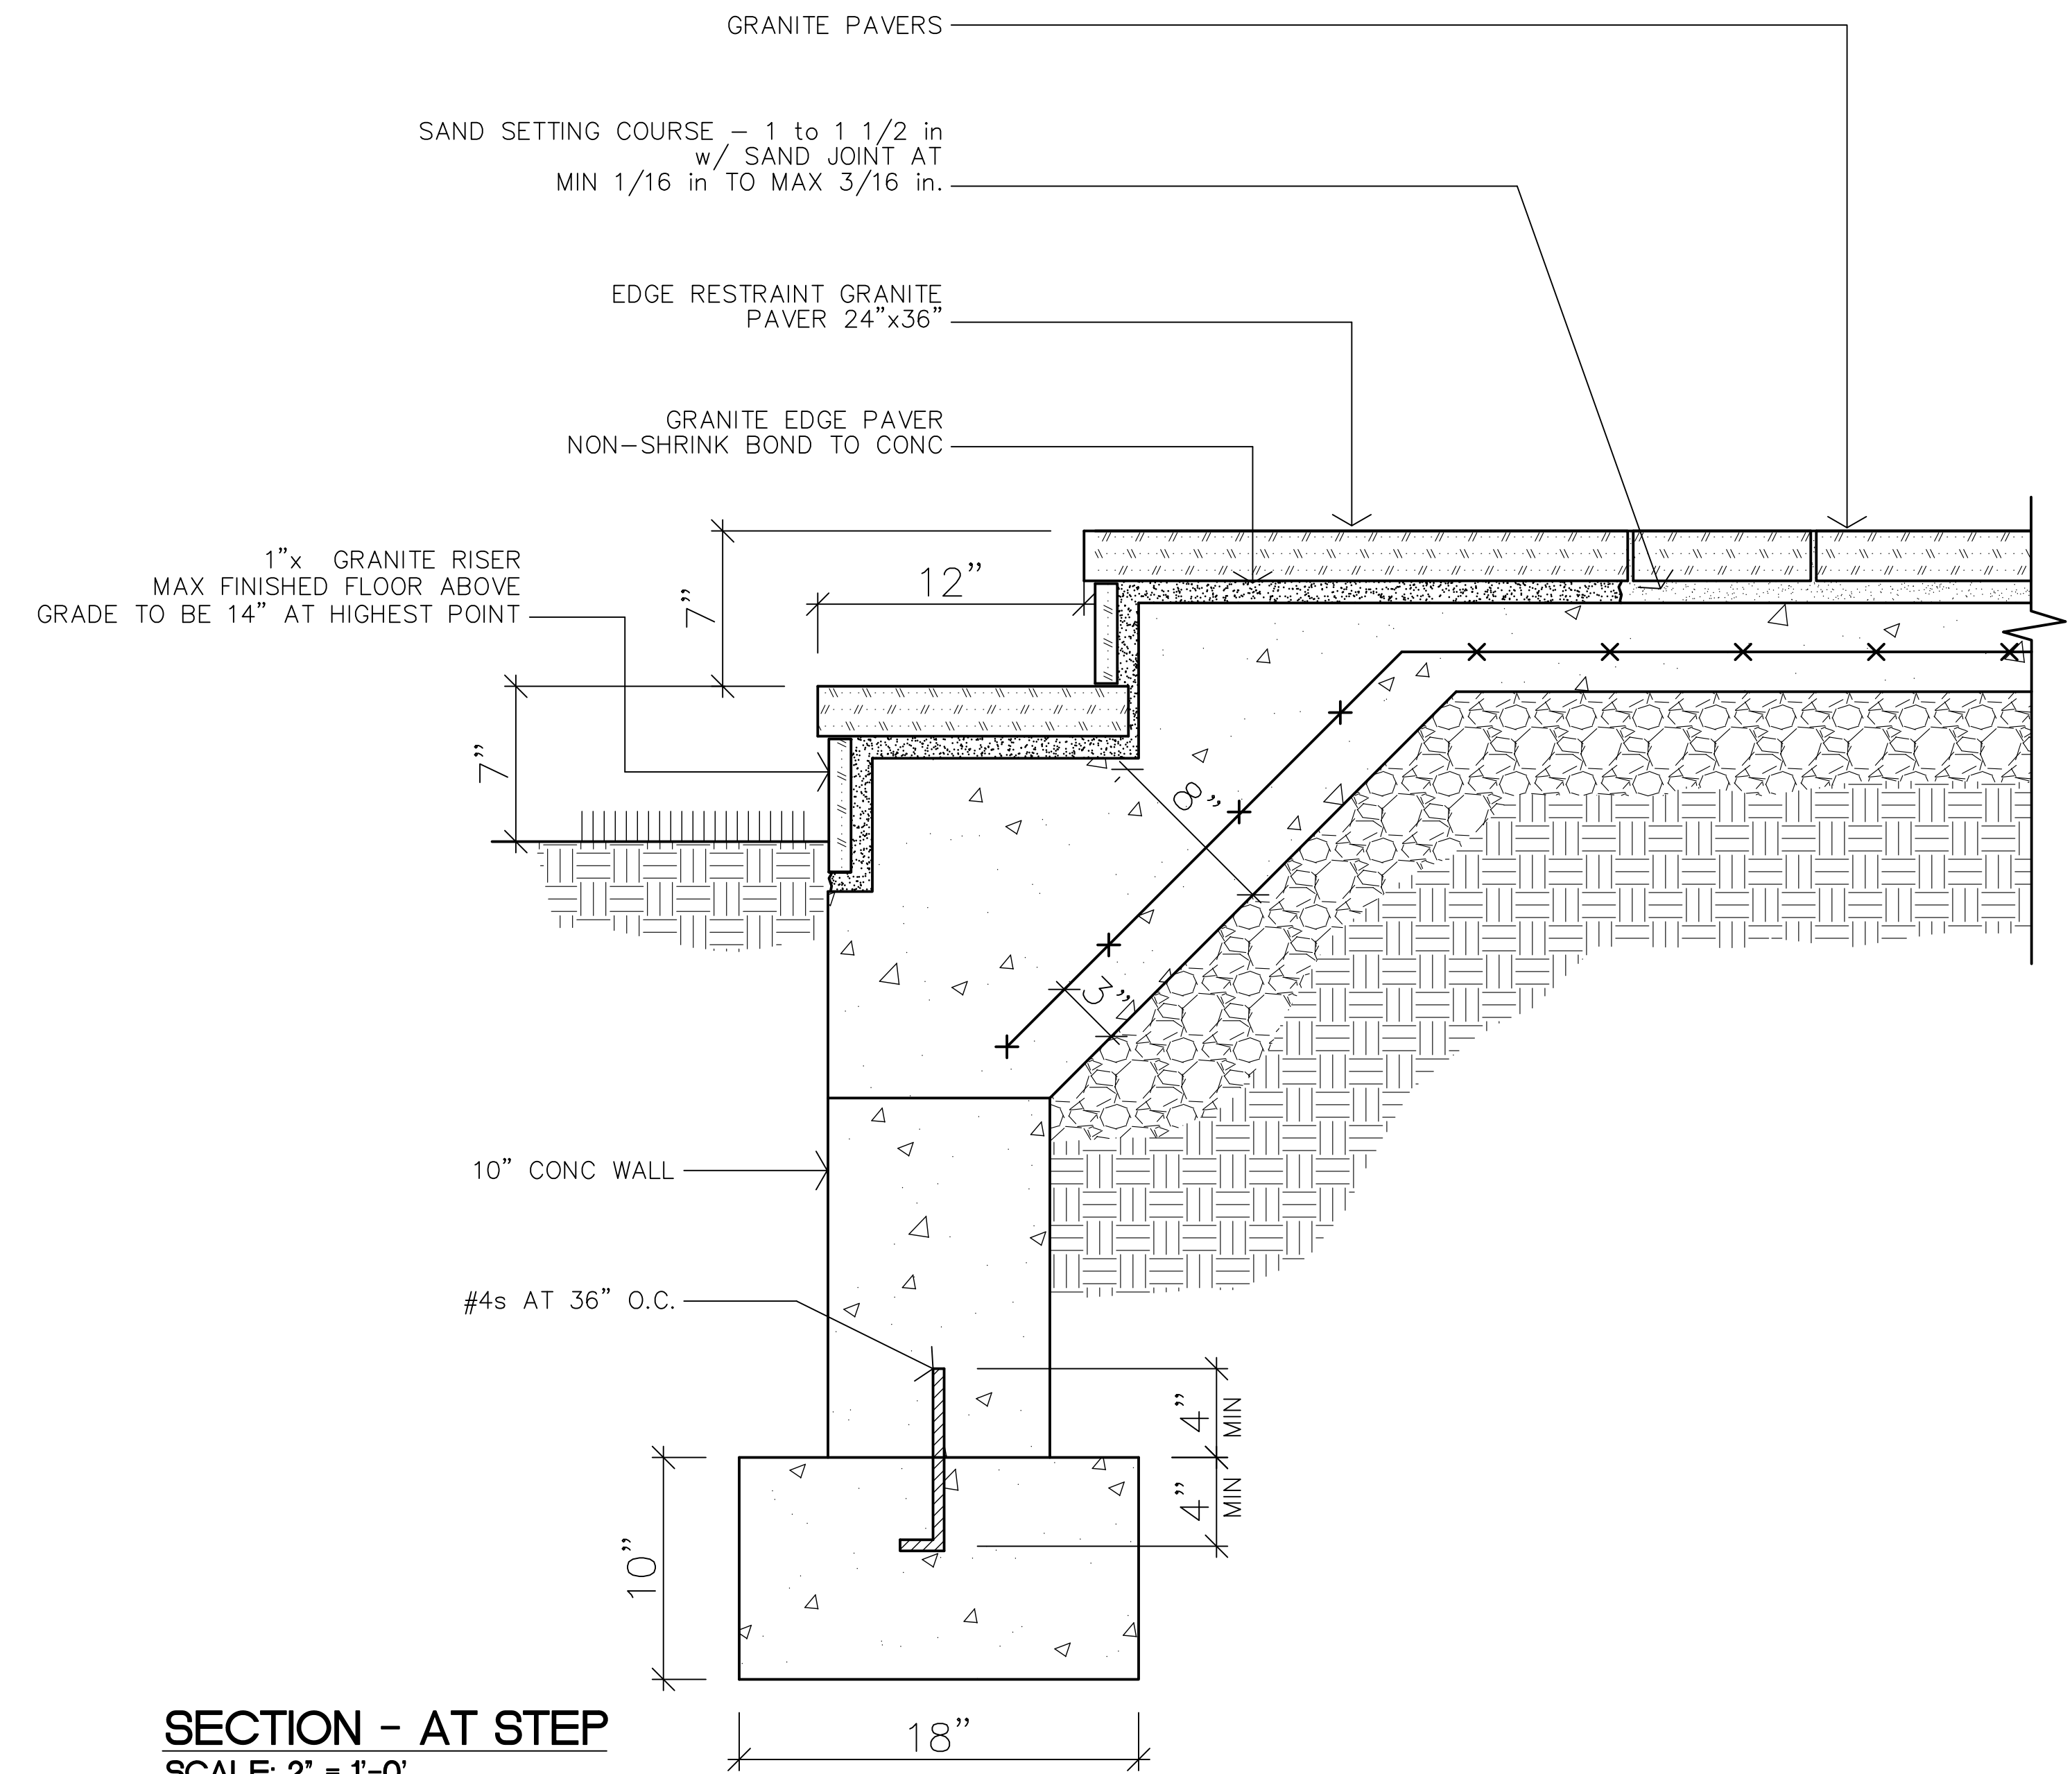

SECTION - AT STEP
SCALE: 2" = 1'-0"

323 SOUTH YORK ROAD
HATBORO, PA 19040
TEL 215.442.1780
FAX 215.442.1781
THEOMNIAGROUP.COM
THEOMNIAGROUP
ARCHITECTS

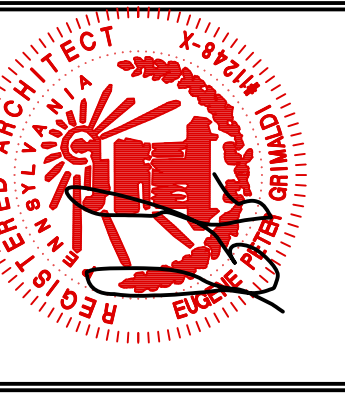

The Lower Makefield Veteran's Monument
Veterans Square Foundation
Corner of Heacock and Edgewood Rd, Yardley PA

DRAWING DATE	03/26/14
REVISION DATES	

A-4